



WEST HEATING PLANT (WHP)

MAIN ENTRANCE ON FIRST FLOOR

If you need assistance, or an accommodation to access an office or classroom please contact:
For Student - Disability Resource Center at (503) 725-4150
For Employees - Human Resources at (503) 725-4926

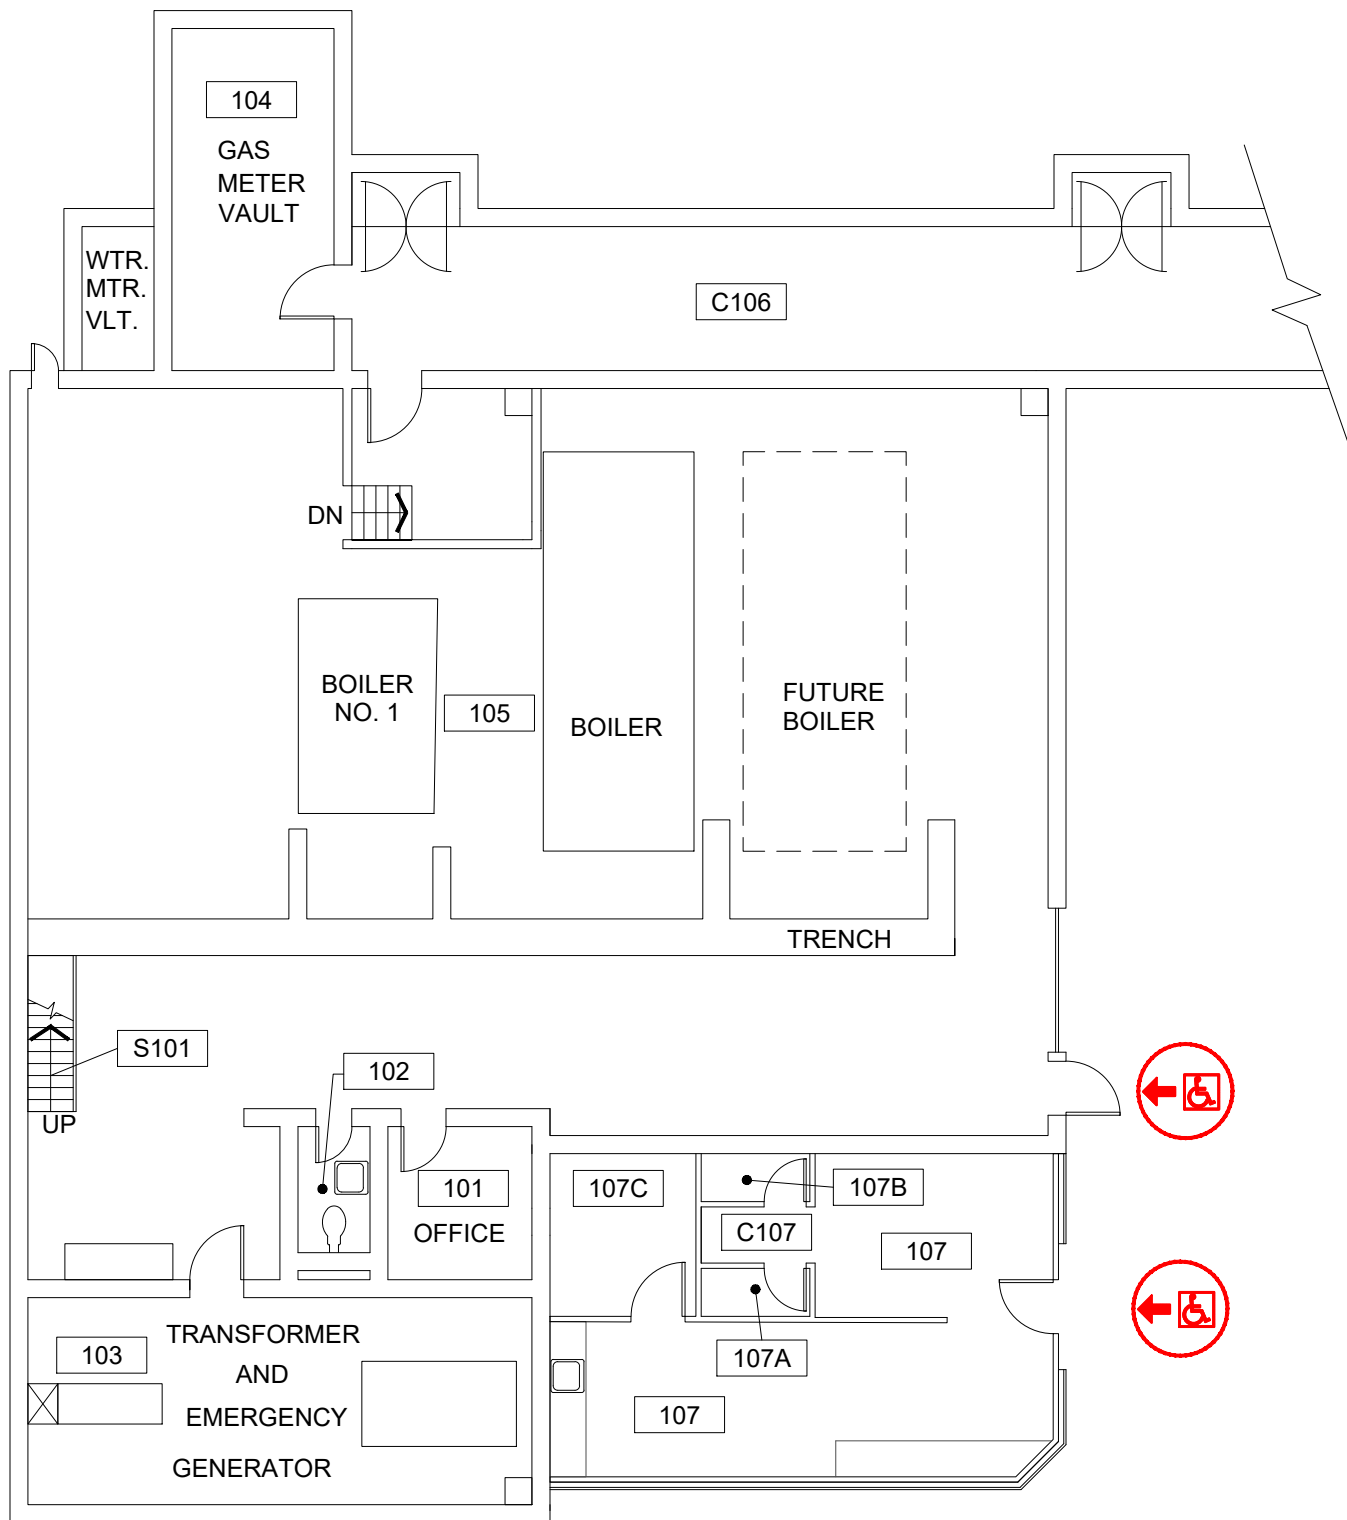

 Scale
 $3/32" = 1'-0"$



ELEVATOR ACCESS



WHEELCHAIR ACCESS




BUILDING ACCESS - NOT
 WHEELCHAIR ACCESSIBLE




FIRST FLOOR PLAN
 West Heating Plant
 SW 11th & Hall

DRAWN BY:
 HH
 DATE:
 06/2018

238_A1

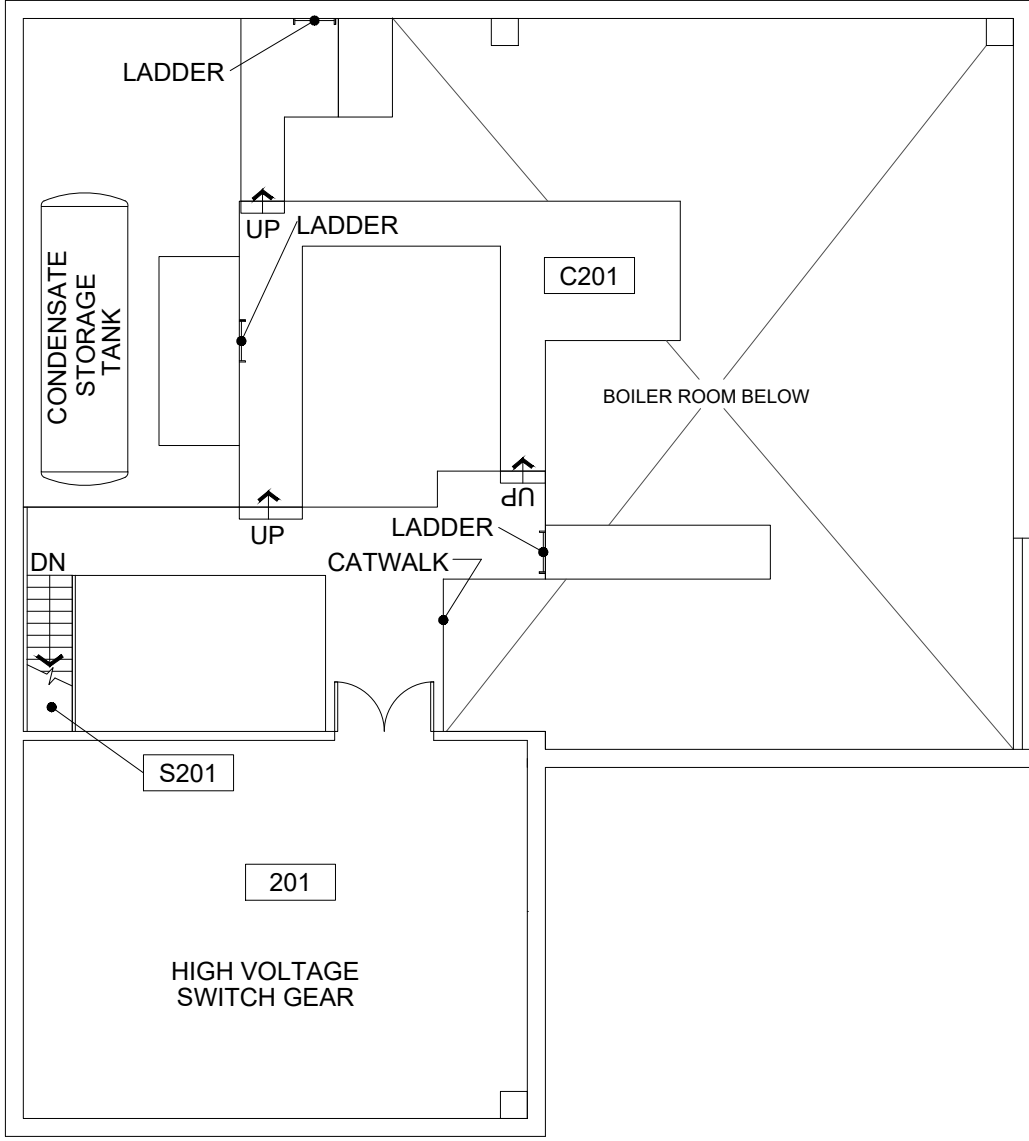


Scale
 $\frac{3}{32}'' = 1'-0''$

 


SECOND FLOOR PLAN
 West Heating Plant
 SW 11th & Hall

DRAWN BY:
 HH
 DATE:
 06/2018

238_A2

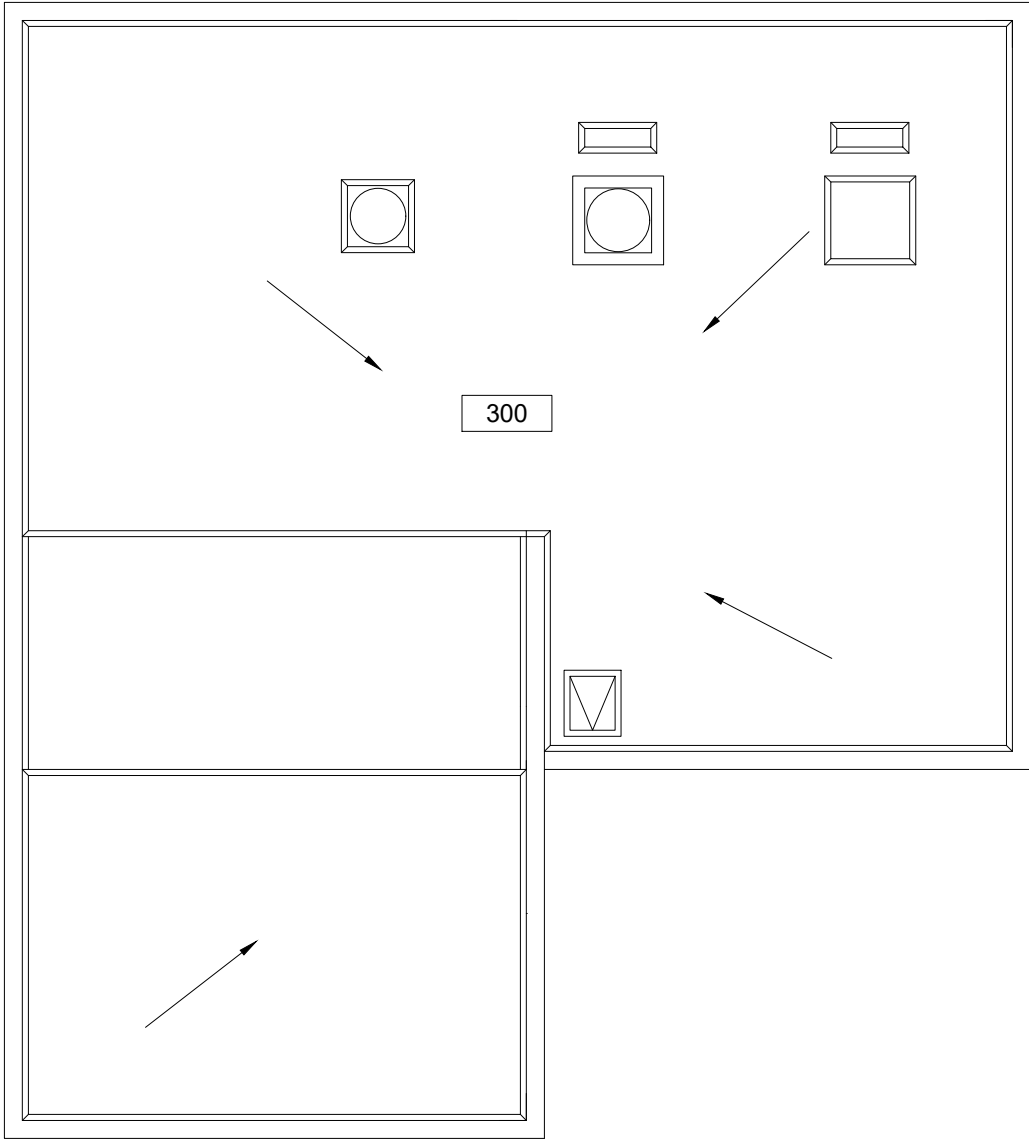

Scale
 $\frac{3}{32}'' = 1'-0''$

 

ROOF PLAN
 West Heating Plant
 SW 11th & Hall

DRAWN BY:
 HH
 DATE:
 06/2018

238_A3